


For Information Only

By P. van Kampen on Dec 16, 2013

TEBODIN

Manufacturers and vendors remain responsible for the content of their documents under all circumstances.

NSL001

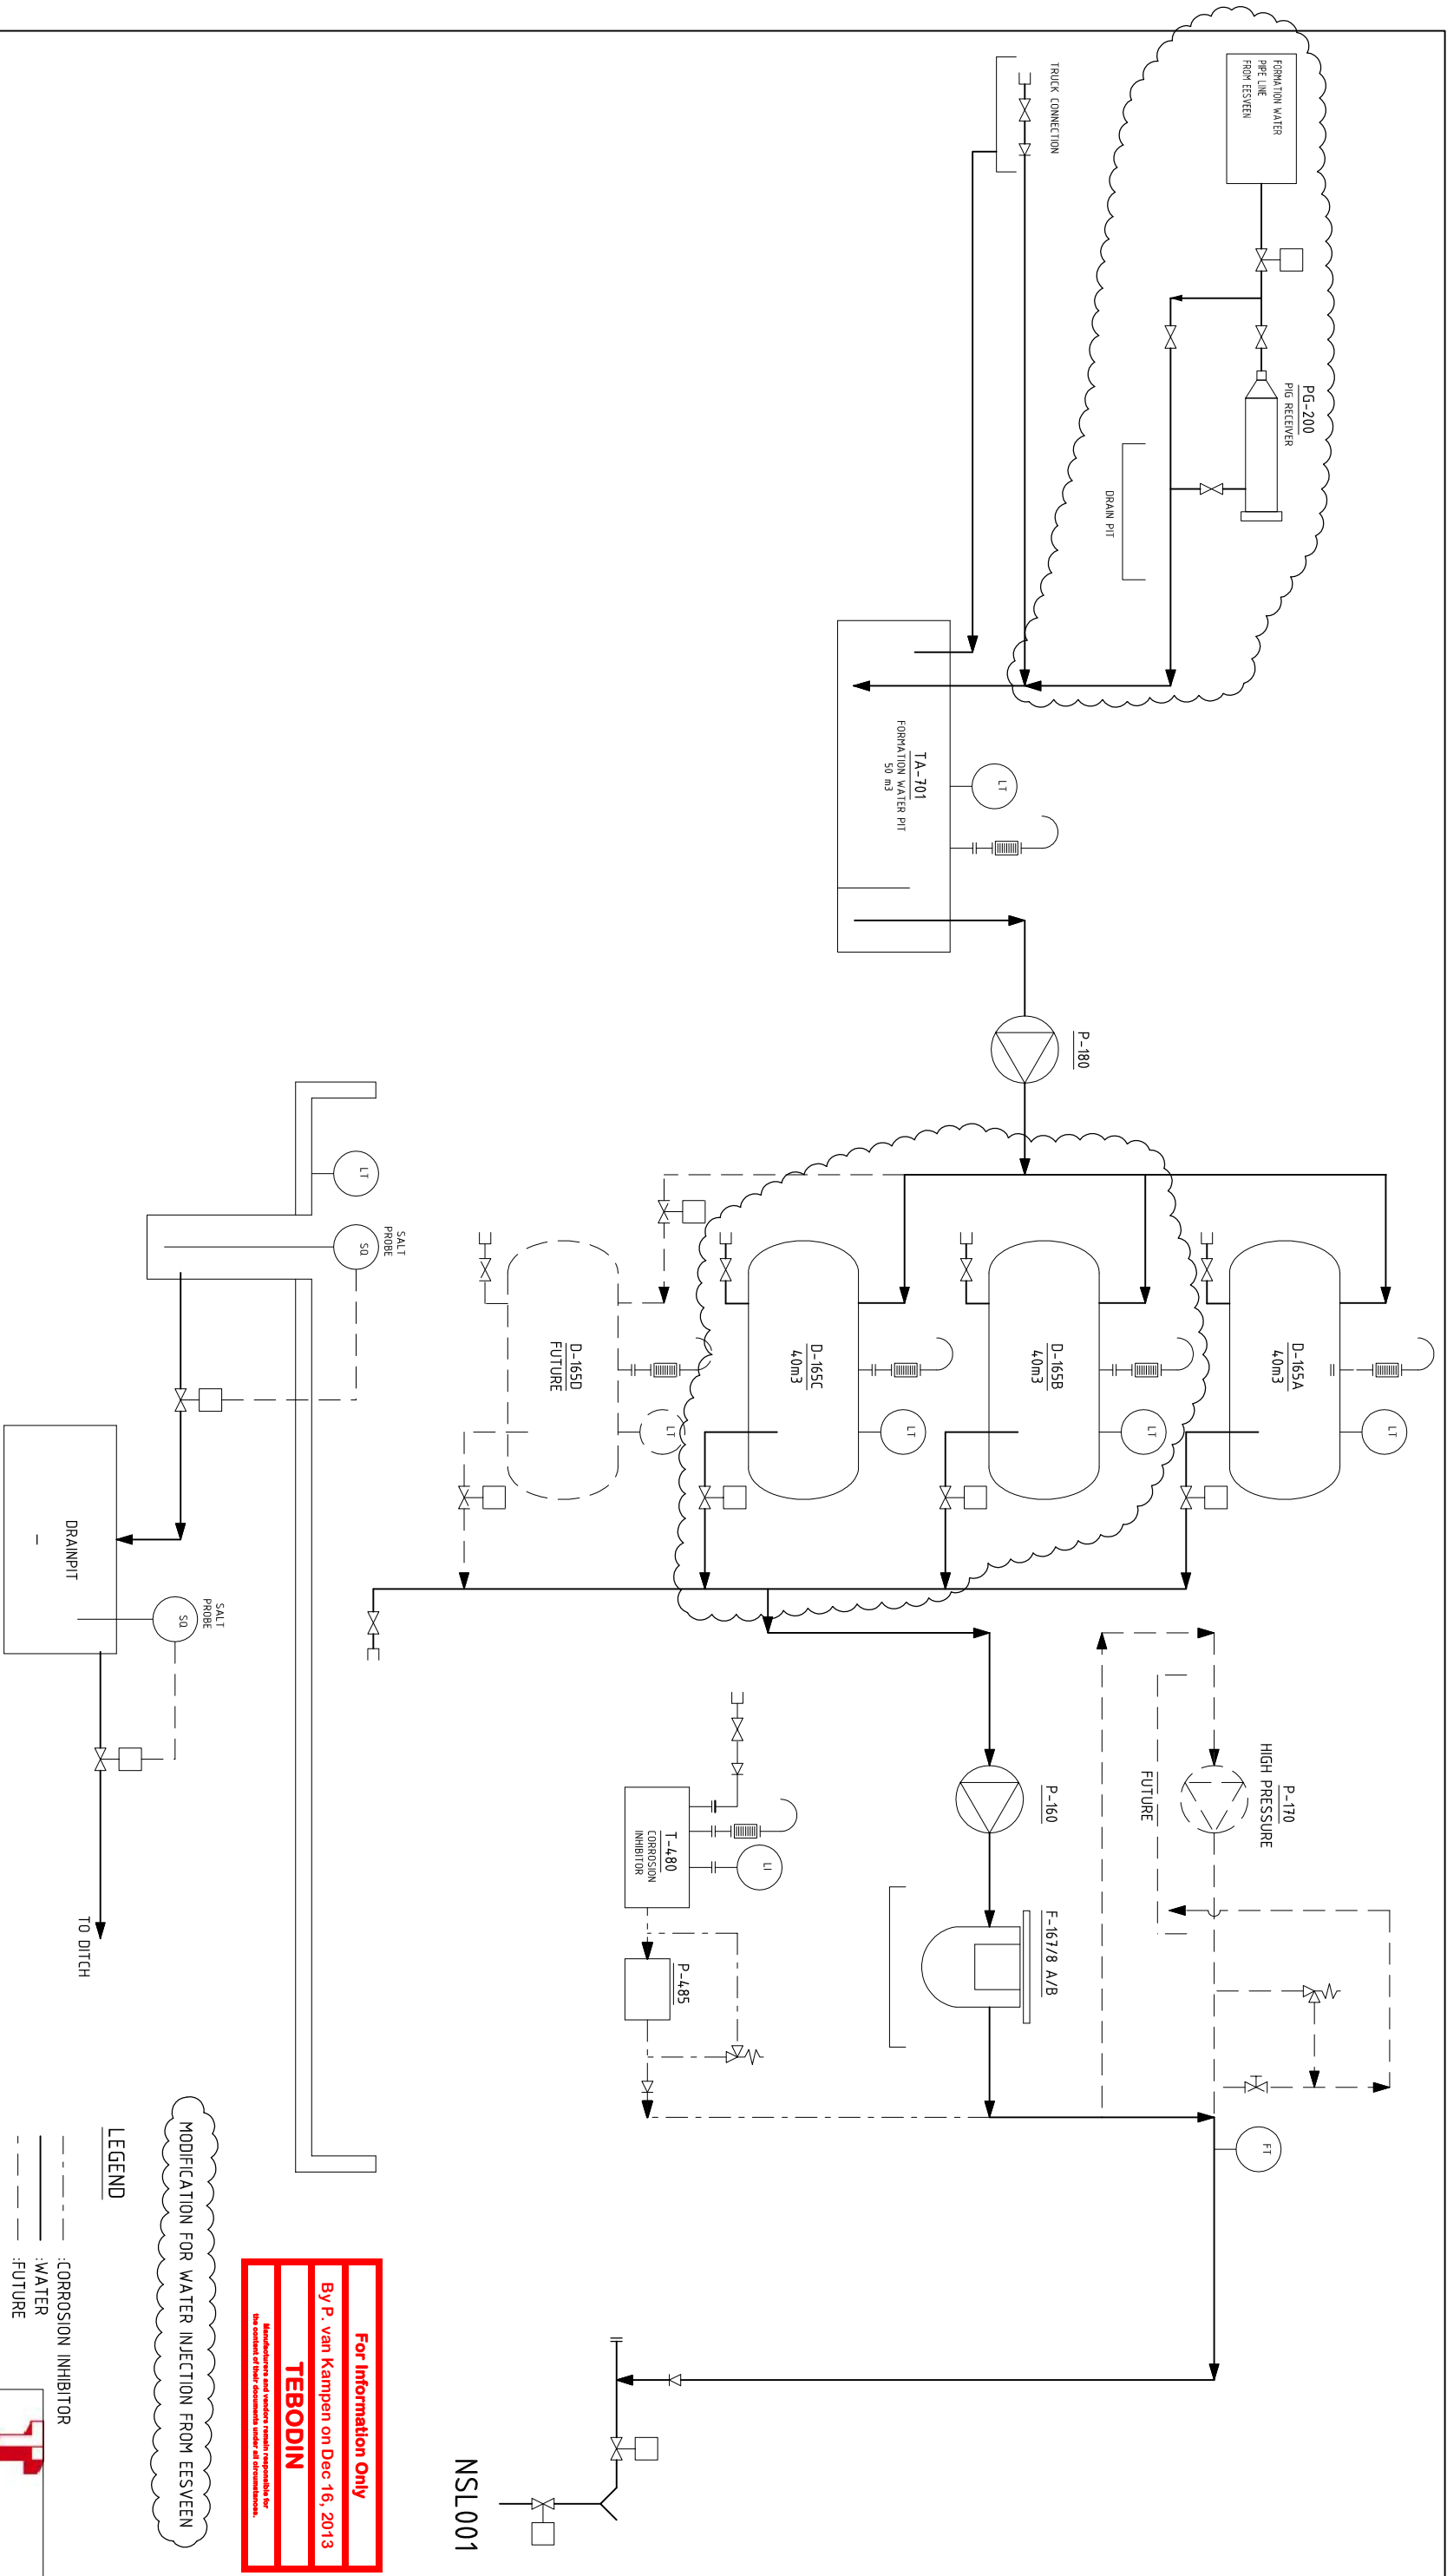

OPMERKINGEN					
1-					
6A	09-12-2013	WATER INJECTION FROM EESVEEN, FOR COMMENTS			
6	01-04-2011	AS BUILT NIJENSLEEK WATER INJECTION			
5A	28-04-2010	REC NIJENSLEEK WATERINJECTIE			
5	04-03-2009	VERGUNNINGSAANVRAAG			
4	12-05-2006	NEW BOOSTER COMPRESSOR			
3	0-04-2006	NEW BOOSTER COMPRESSOR			
2	01-12-2000	AS BUILT			
6B	16-12-2013	WATERINJECTION FROM EESVEEN, FOR PERMITTING			
0	21-10-1998	FINAL ISSUE			
REV.	DATE	DESCRIPTION	DRWN	CHK'D	APPR.
TITLE: PROCESS FLOW DIAGRAM					
REF. No.: -			C/D No.: -		
SCALE:	SIZE:	DRAWING NUMBER:	SHEET:		
NONE	A2	1-34-NS001-3-31-104-001	001		
LOCATION: WELLSITE NIJENSLEEK-1					
WELLS: NS001					